


Infinity Hot water unit to showers will be done. Final location of unit has not been established as yet. To be finalised next week.

All normal carpet has been replaced by vinyl. All floor coverings will now be vinyl.

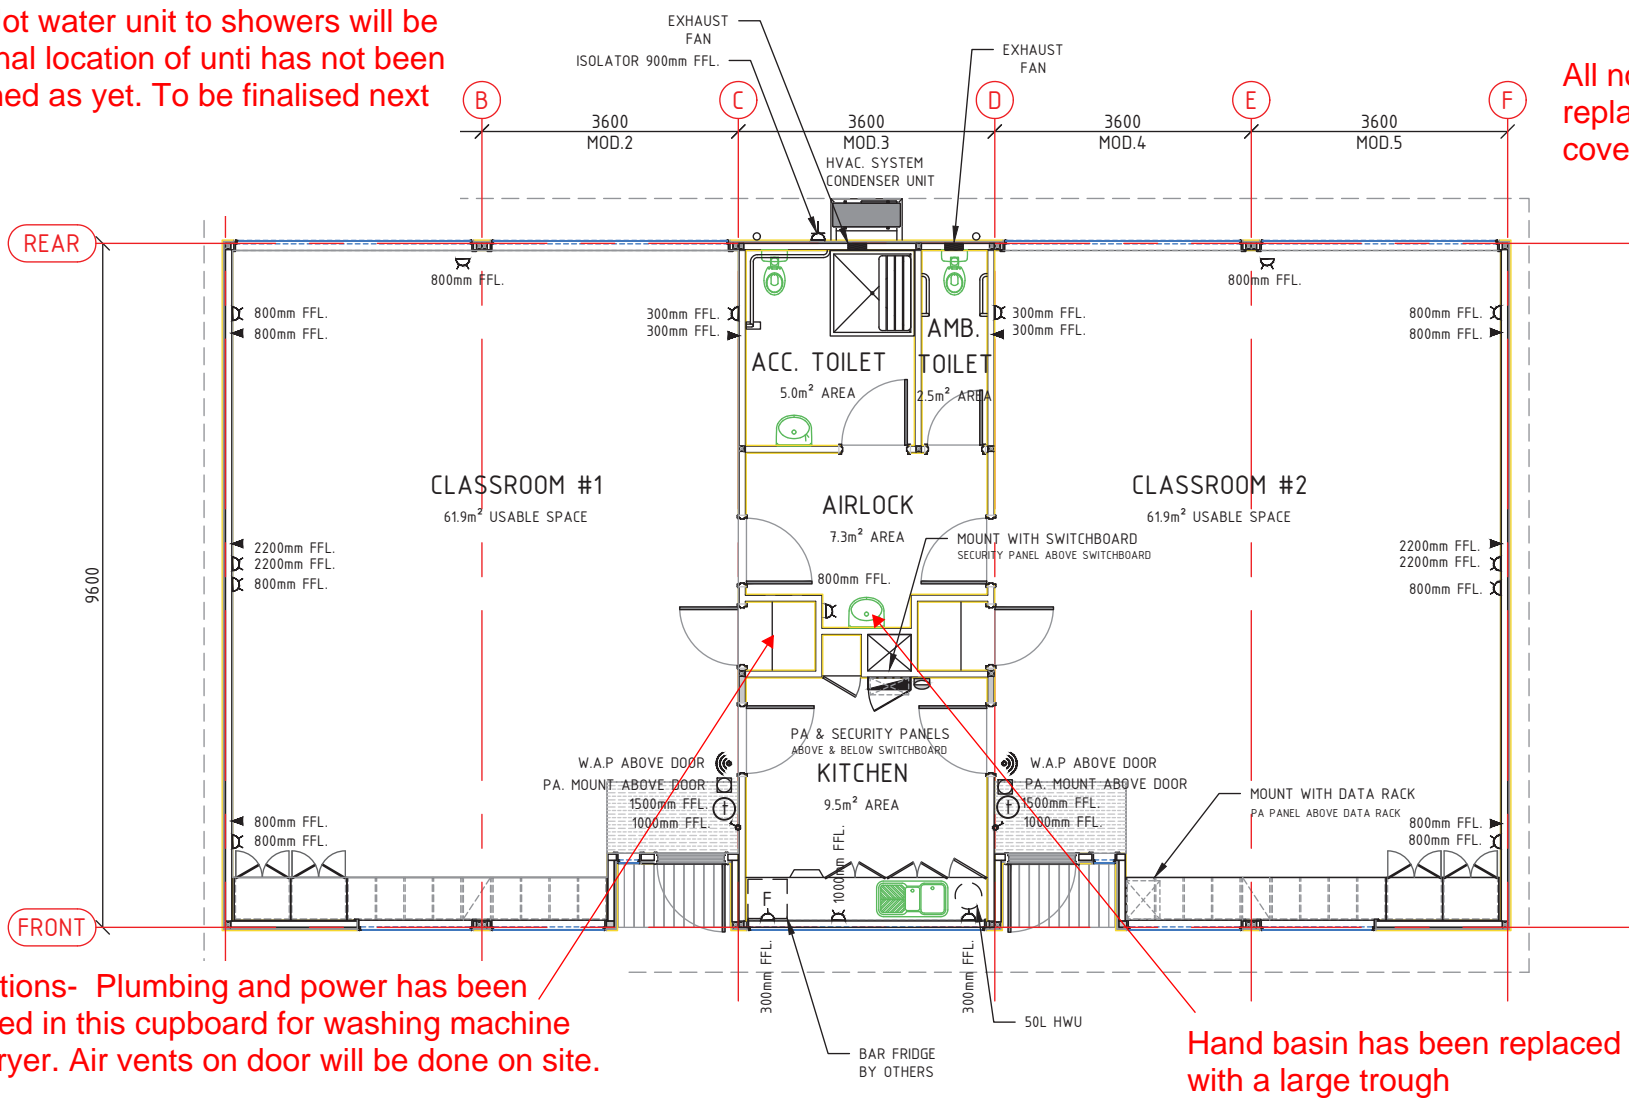

Alterations- Plumbing and power has been installed in this cupboard for washing machine and dryer. Air vents on door will be done on site.

Hand basin has been replaced with a large trough

ENGINEERED
DRAWINGS
BY ANY
UNLICENSED
PERSON
OR LOANED
PERSON
MAY BE
PROSECUTED

ALL DRAWINGS ARE
THE PROPERTY OF
GROVE (AUST) PTY LTD AT ALL
TIMES. NO PART THEREOF MAY BE
REPRODUCED OR LOANED IN ANY
FORM OR MANNER WITHOUT THE
WRITTEN CONSENT OF THE
ENGINEER.

GROVE

ELECTRICAL LEGEND				
▽ DOUBLE CAT6 DATA POINT	⊕ HVAC THERMOSTAT AND CONTROL POINT	⚡ ISOLATOR	⊞ PA. TERMINATION	⊞ BUILDING MANAGEMENT SYSTEM CONTROL PANEL
▽ SINGLE CAT6 DATA POINT	⊞ DOUBLE GPO	⊞ DATA RACK	⊞ SWITCHBOARD	⊞ W.A.P - WIRELESS ACCESS POINT
▽ TELEPHONE DATA POINT	⊞ SINGLE GPO	⊞ SECURITY PANEL	⊞ PA SPEAKER (RECESSED)	

ELECTRICAL FLOOR PLAN

PLEASE SIGN BELOW TO CONFIRM THE DRAWINGS ARE CORRECT. THE DRAWINGS SUPERSEDE ALL OTHER GROVE CORRESPONDENCE AND REFLECT THE BUILDING THAT WILL BE CONSTRUCTED

GROVE
5 Mega Rise, Pakenham 3810
Tel: 1300 30 80 11
Fax: 1300 88 10 76
Website: www.grovetgroup.com.au

REV.	DESCRIPTION
15.09.15	0 ISSUED FOR CONSTRUCTION
09.09.15	C ISSUED FOR CLIENT APPROVAL (INTERNAL REVIEW & SIGN OFF COMPLETE)
28.08.15	B INTERNAL REVIEW AND APPROVAL
31.07.15	A ISSUED FOR DISCUSSION
	ISSUED REV. DESCRIPTION

WELD NOTES

- ALL ADJOINING PLATES AND SECTIONS ARE TO BE WELDED WITH 6mm CONTINUOUS FILLET OR FULL PENETRATION BUTT WELD UNLESS NOTED OTHERWISE.
- ALL SHS TRUSS FRAMES TO BE 3mm CONTINUOUS FILLET WELD AT ADJOINING SECTIONS.
- ALL LIFTING LUGS AND ASSOCIATED STIFFENER PLATES TO BE 8mm CONTINUES FILLET WELD ALL AROUND.
- ALL PURLINS TO BE 3mm CONTINUOUS FILLET WELD TO BOTH SIDES OF WEB. SPOT WELD TO PURLIN TOES.
- COMPOSITE BEAMS AND POSTS TO BE 6mm STITCH WELD HIT 100mm PRES 200 STAGGERED BOTH SIDES.
- HIT 200 AT ENDS, TOPS & BOTTOMS (ISEQUENCE WELDS AND CHANGE WELD DIRECTIONS TO SUIT GROVE BEST PRACTICE AND MINIMISE FRAME DISTORTION)
- ALL SECONDARY NON-STRUCTURAL ELEMENTS SUCH AS HANDRAIL, BALUSTRADE, SEATING, CONDENSER CAGES & SHELVES/FURNITURE TO BE 3mm CONTINUOUS FILLET WELD AS NOTED ON DRAWINGS.
- PPC PERIMETER FRAME CORNER JOINS (BASE & ROOF FRAMES) TO BE 12mm CONTINUOUS FILLET WELD AT BACKS OF WEB. POST TO BE INTEGRATED INTO FRAME WITH 6mm CONTINUOUS FILLET WELD TO FLANGES AND WEBS.
- UNLESS NOTED OTHERWISE, ALL BOLTS ARE TO BE STRUCTURAL GRADE

Builder:
GROVE (Aust) PTY LTD
DRAWN: J.H. DATE: JUL'15
CHECKED: S.S. SCALE: 1:75@A3
SIGNED:

D.E.T. 5 MOD. (SDS)
2015 GROVE Pty. Ltd. DESIGN
PRELIMINARY ISSUE
QUOTE NO. QV677
JOB NO. GV081501
DRAWING NO. A-011
REV. 0

Approved by: